



FIRST FLOOR REFLECTED CEILING PLAN

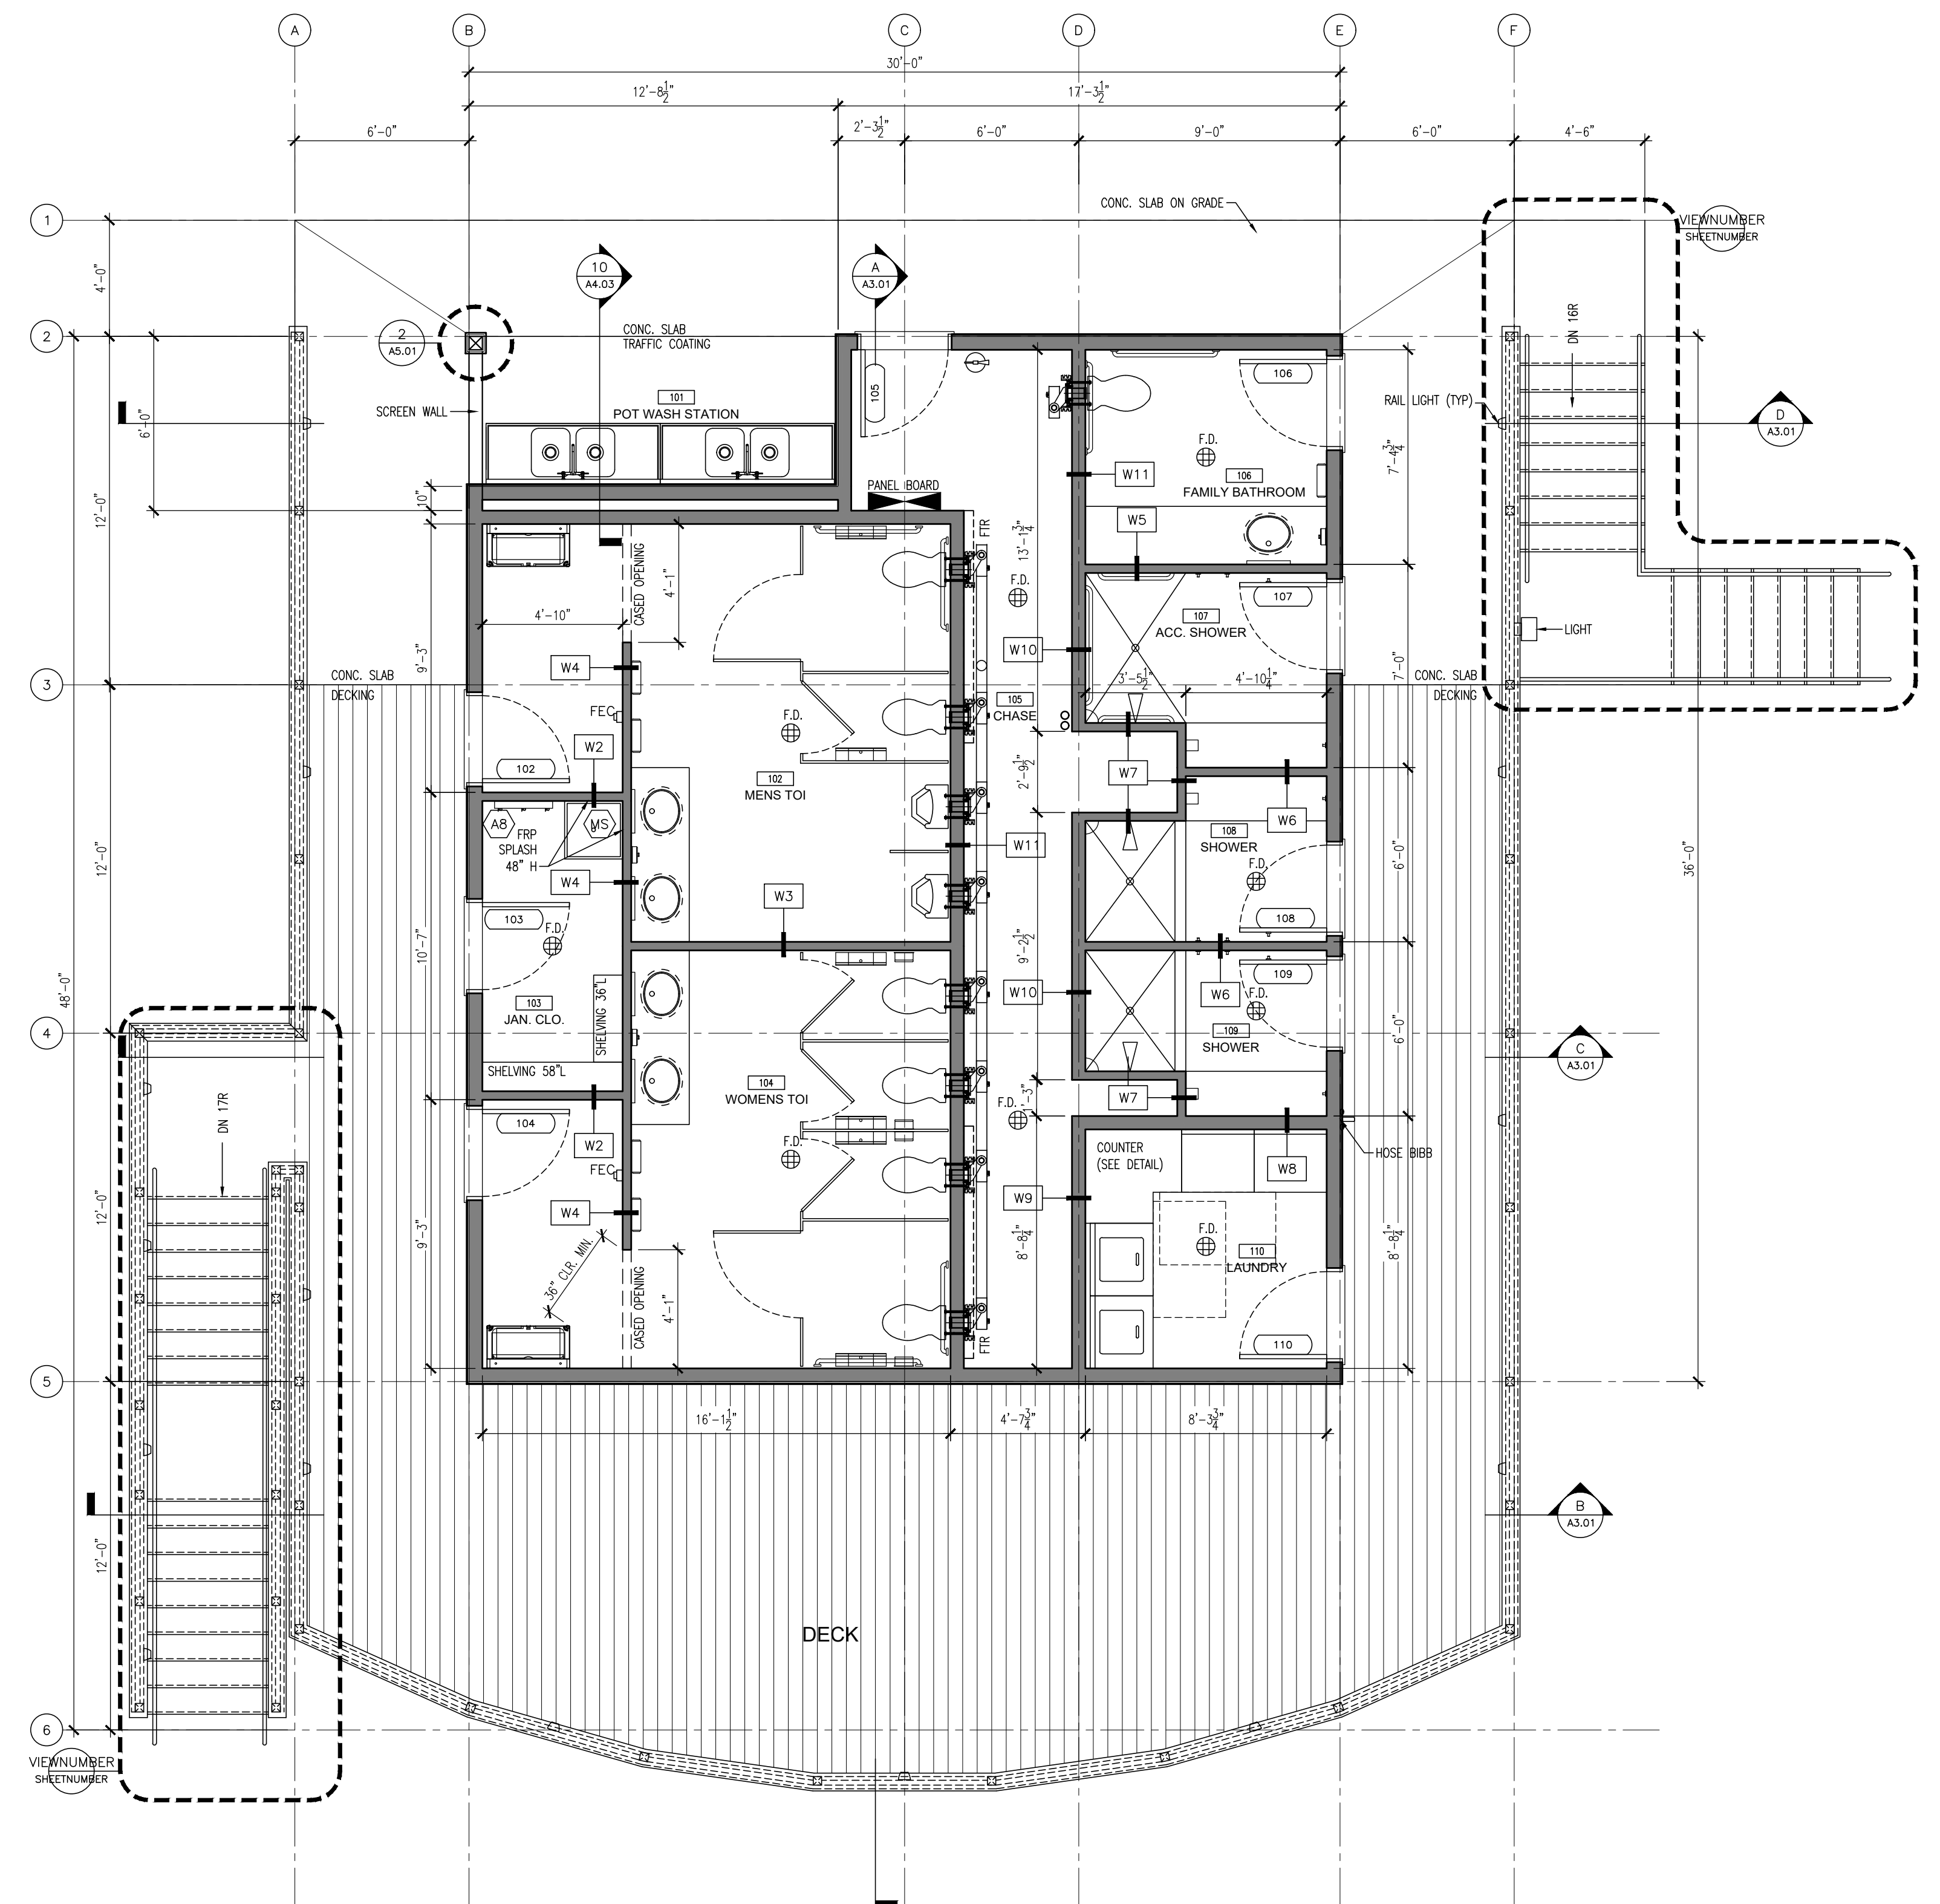

FIRST FLOOR PLAN

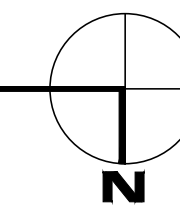

90% REVIEW SUBMISSION
NOT FOR CONSTRUCTION

STATE OF NEW HAMPSHIRE DEPARTMENT OF ADMINISTRATIVE SERVICES DIVISION OF PUBLIC WORKS DESIGN & CONSTRUCTION JOHN O. MORTON BUILDING 7 HAZEN DRIVE BOX 483 ROOM 250 CONCORD, NEW HAMPSHIRE 03302-0483 (603) 271-3516 FAX (603) 271-3515		REVISIONS DATE DESCRIPTION BY		UMBAGOG NEW BATHHOUSE UMBAGOG LAKE STATE PARK 235 EAST RT 26 CAMBRIDGE, NEW HAMPSHIRE	
		PROJECT No. 80875 CONTRACT: E		FIRST FLOOR PLAN & REFLECTED CEILING PLAN PROJECT No. 80875 CONTRACT: E	
ENGINEER/ARCHITECT: DNCR	DESIGNED BY: SDC	APPROVED BY: TM	CHECKED BY: TM	DRAWN BY: SDC	SCALE: 1/4" = 1'-0" DATE: 4/27/2018
				PROJECT No. 80875 CONTRACT: E A1.01 SHEET	